


FACILITY INDEX

BUILDING	NAME
A	WALKER HALL
AA	NURSING BUILDING
B	GRESHAM HALL
C	GRESHAM ANNEX
D	WHITE HALL
DD	PHYSICAL PLANT - CENTRAL
E	FACILITIES ANNEX
F	SHIPPING & RECEIVING
G	PRESIDIO INFORMATION TECHNOLOGY CENTER
H	LEONHARDT HALL
I	ROBINSON HALL
J	LEARNING RESOURCES
K	HENDRY HALL
L	HUMANITIES HALL
M	B.B. MANN PAH
N	ROYAL PALM HALL
O	SABAL HALL
P	ARECA HALL
Q	HOWARD HALL
R	PHYSICAL PLANT - WEST
S	TAENI STUDENT SERVICES HALL
T	CLASSROOM BUILDING
U	CLASSROOM BUILDING
V	LOCKMILLER CHILD DEVELOPMENT CENTER
W	LIGHTHOUSE COMMONS
Z	FOUNDATION

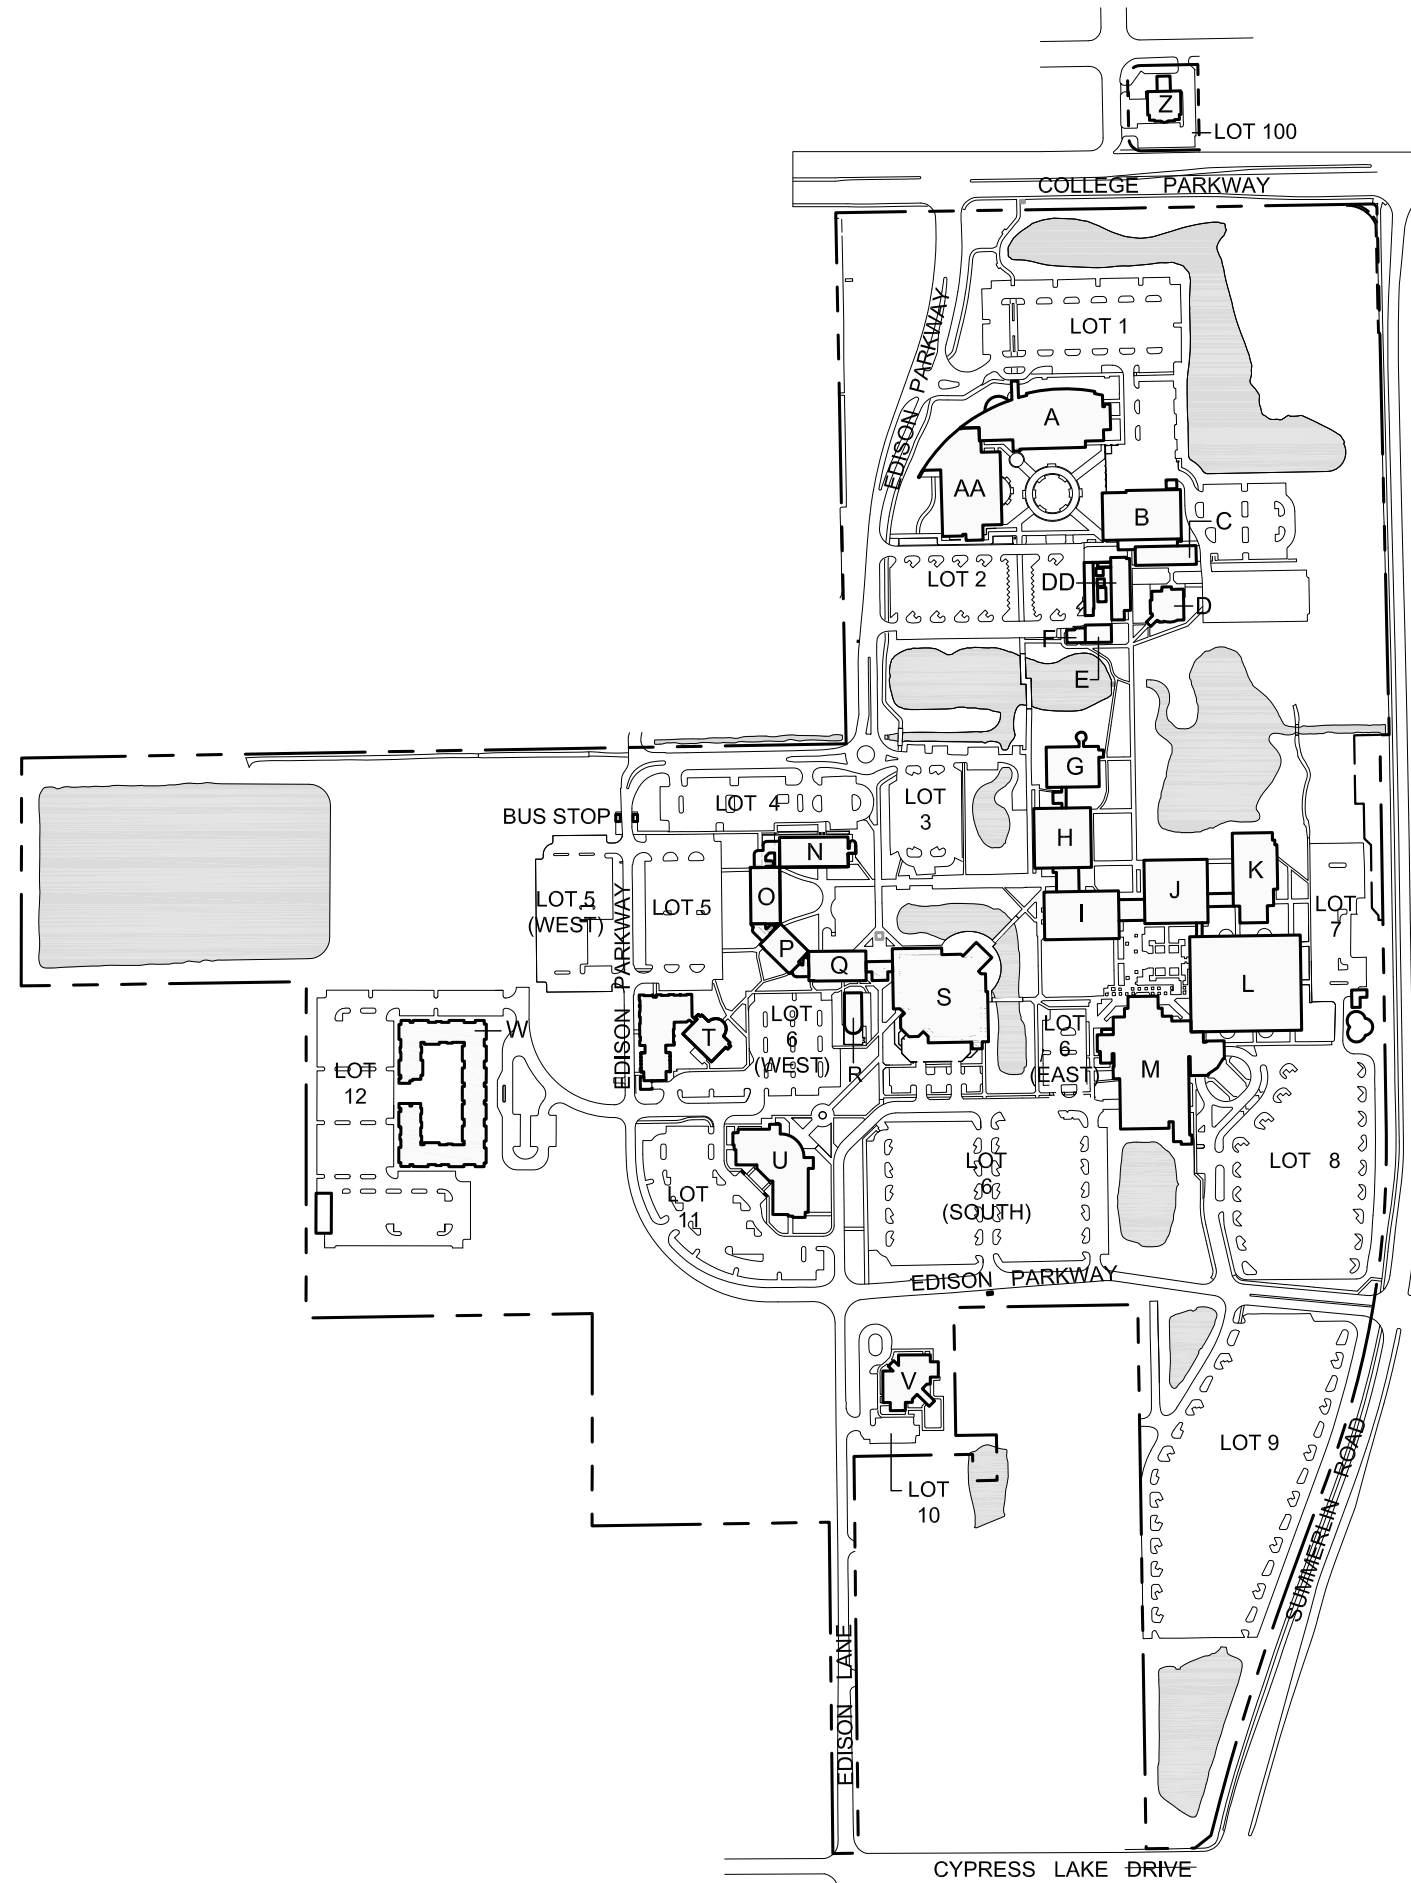

DEPARTMENT OF FACILITIES PLANNING

**SITE PLAN**  
8099 COLLEGE PKWY.  
LEE CAMPUS

LEE COUNTY  
FORT MYERS, FLORIDA

DISCLAIMER  
DRAWING INFORMATION  
ACCURATE FOR PLANNING  
PURPOSES ONLY. VERIFY ALL  
INFORMATION AS REQUIRED.

REVISION

DESC.	DATE
ISSUED TO AGENCIES	10/01/13

AREA  
SITE PLAN 140 ACRES



SITE PLAN  
SCALE: NOT TO SCALE

SHEET NUMBER:  
**1**